

**Midwestern State University  
Wichita Falls Museum of Art  
HVAC System Modifications**  
2, Enreke Cir.  
Wichita Falls, TX 76088



**DATE ISSUED:**  
DEC. 06, 2021

**ISSUES:**  
ISSUED FOR REVIEW 11-29-2021  
ISSUED FOR CONST. 12-06-2021


**REVISIONS:**


**SHEET CONTENTS:**  
ELECTRICAL FLOOR PLAN

**SHEET NUMBER:**  
**E2.1**

**NOTES BY SYMBOL "1"**

1 PROVIDE NEW CIRCUIT FROM (E)PANEL - L. INSTALL 40-AMP, 3 POLE CIRCUIT BREAKER IN NEXT OPEN SPACE IN PANEL-L. (DRAWINGS INDICATE 12 AVAILABLE SPACES IN THE EXISTING PANEL). ROUTE 3/8" #10G, 1"Ø FROM THE NEW CIRCUIT BREAKER TO THE DUCT HEATER. DUCT HEATER PROVIDED WITH DISCONNECT SWITCH.

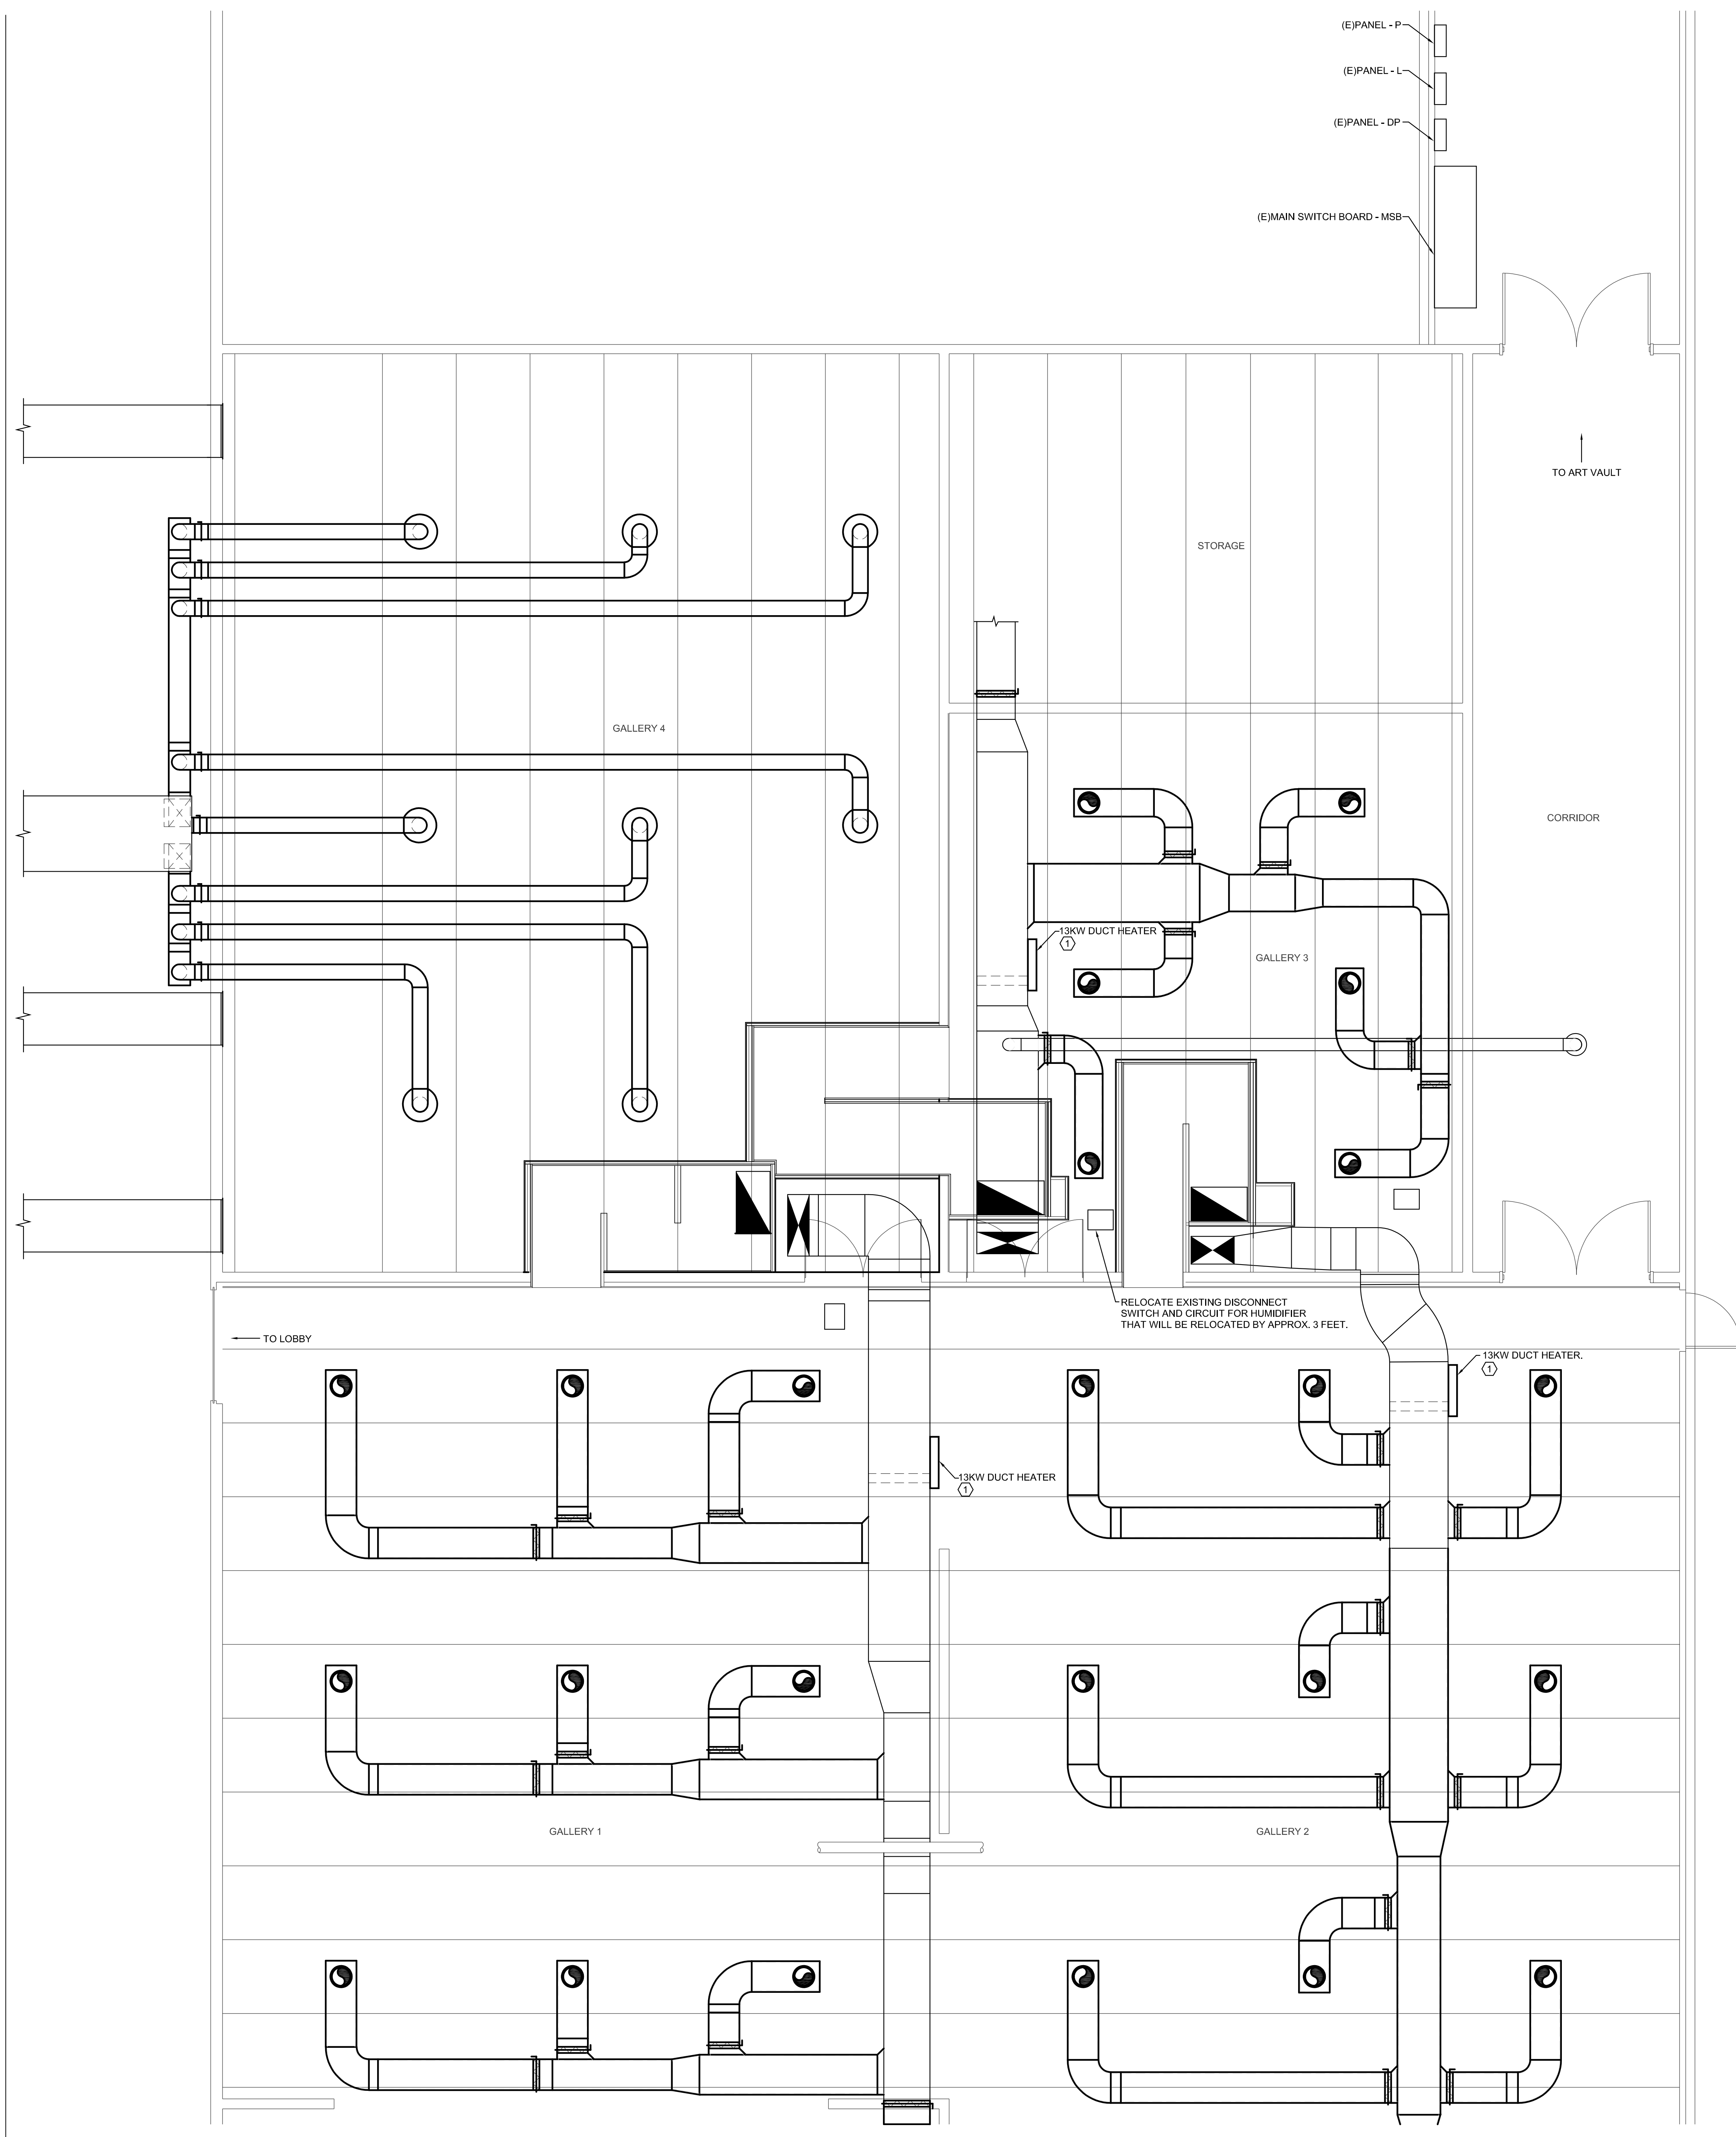

**1 ELECTRICAL FLOOR PLAN**  
SCALE: 1/4" = 1'-0"

